


The contents of this drawing are the property of C3 Projects Ltd and are copyright protected. No contents of this drawing may be reproduced in whole or in part without the prior written permission of C3 Projects Ltd.

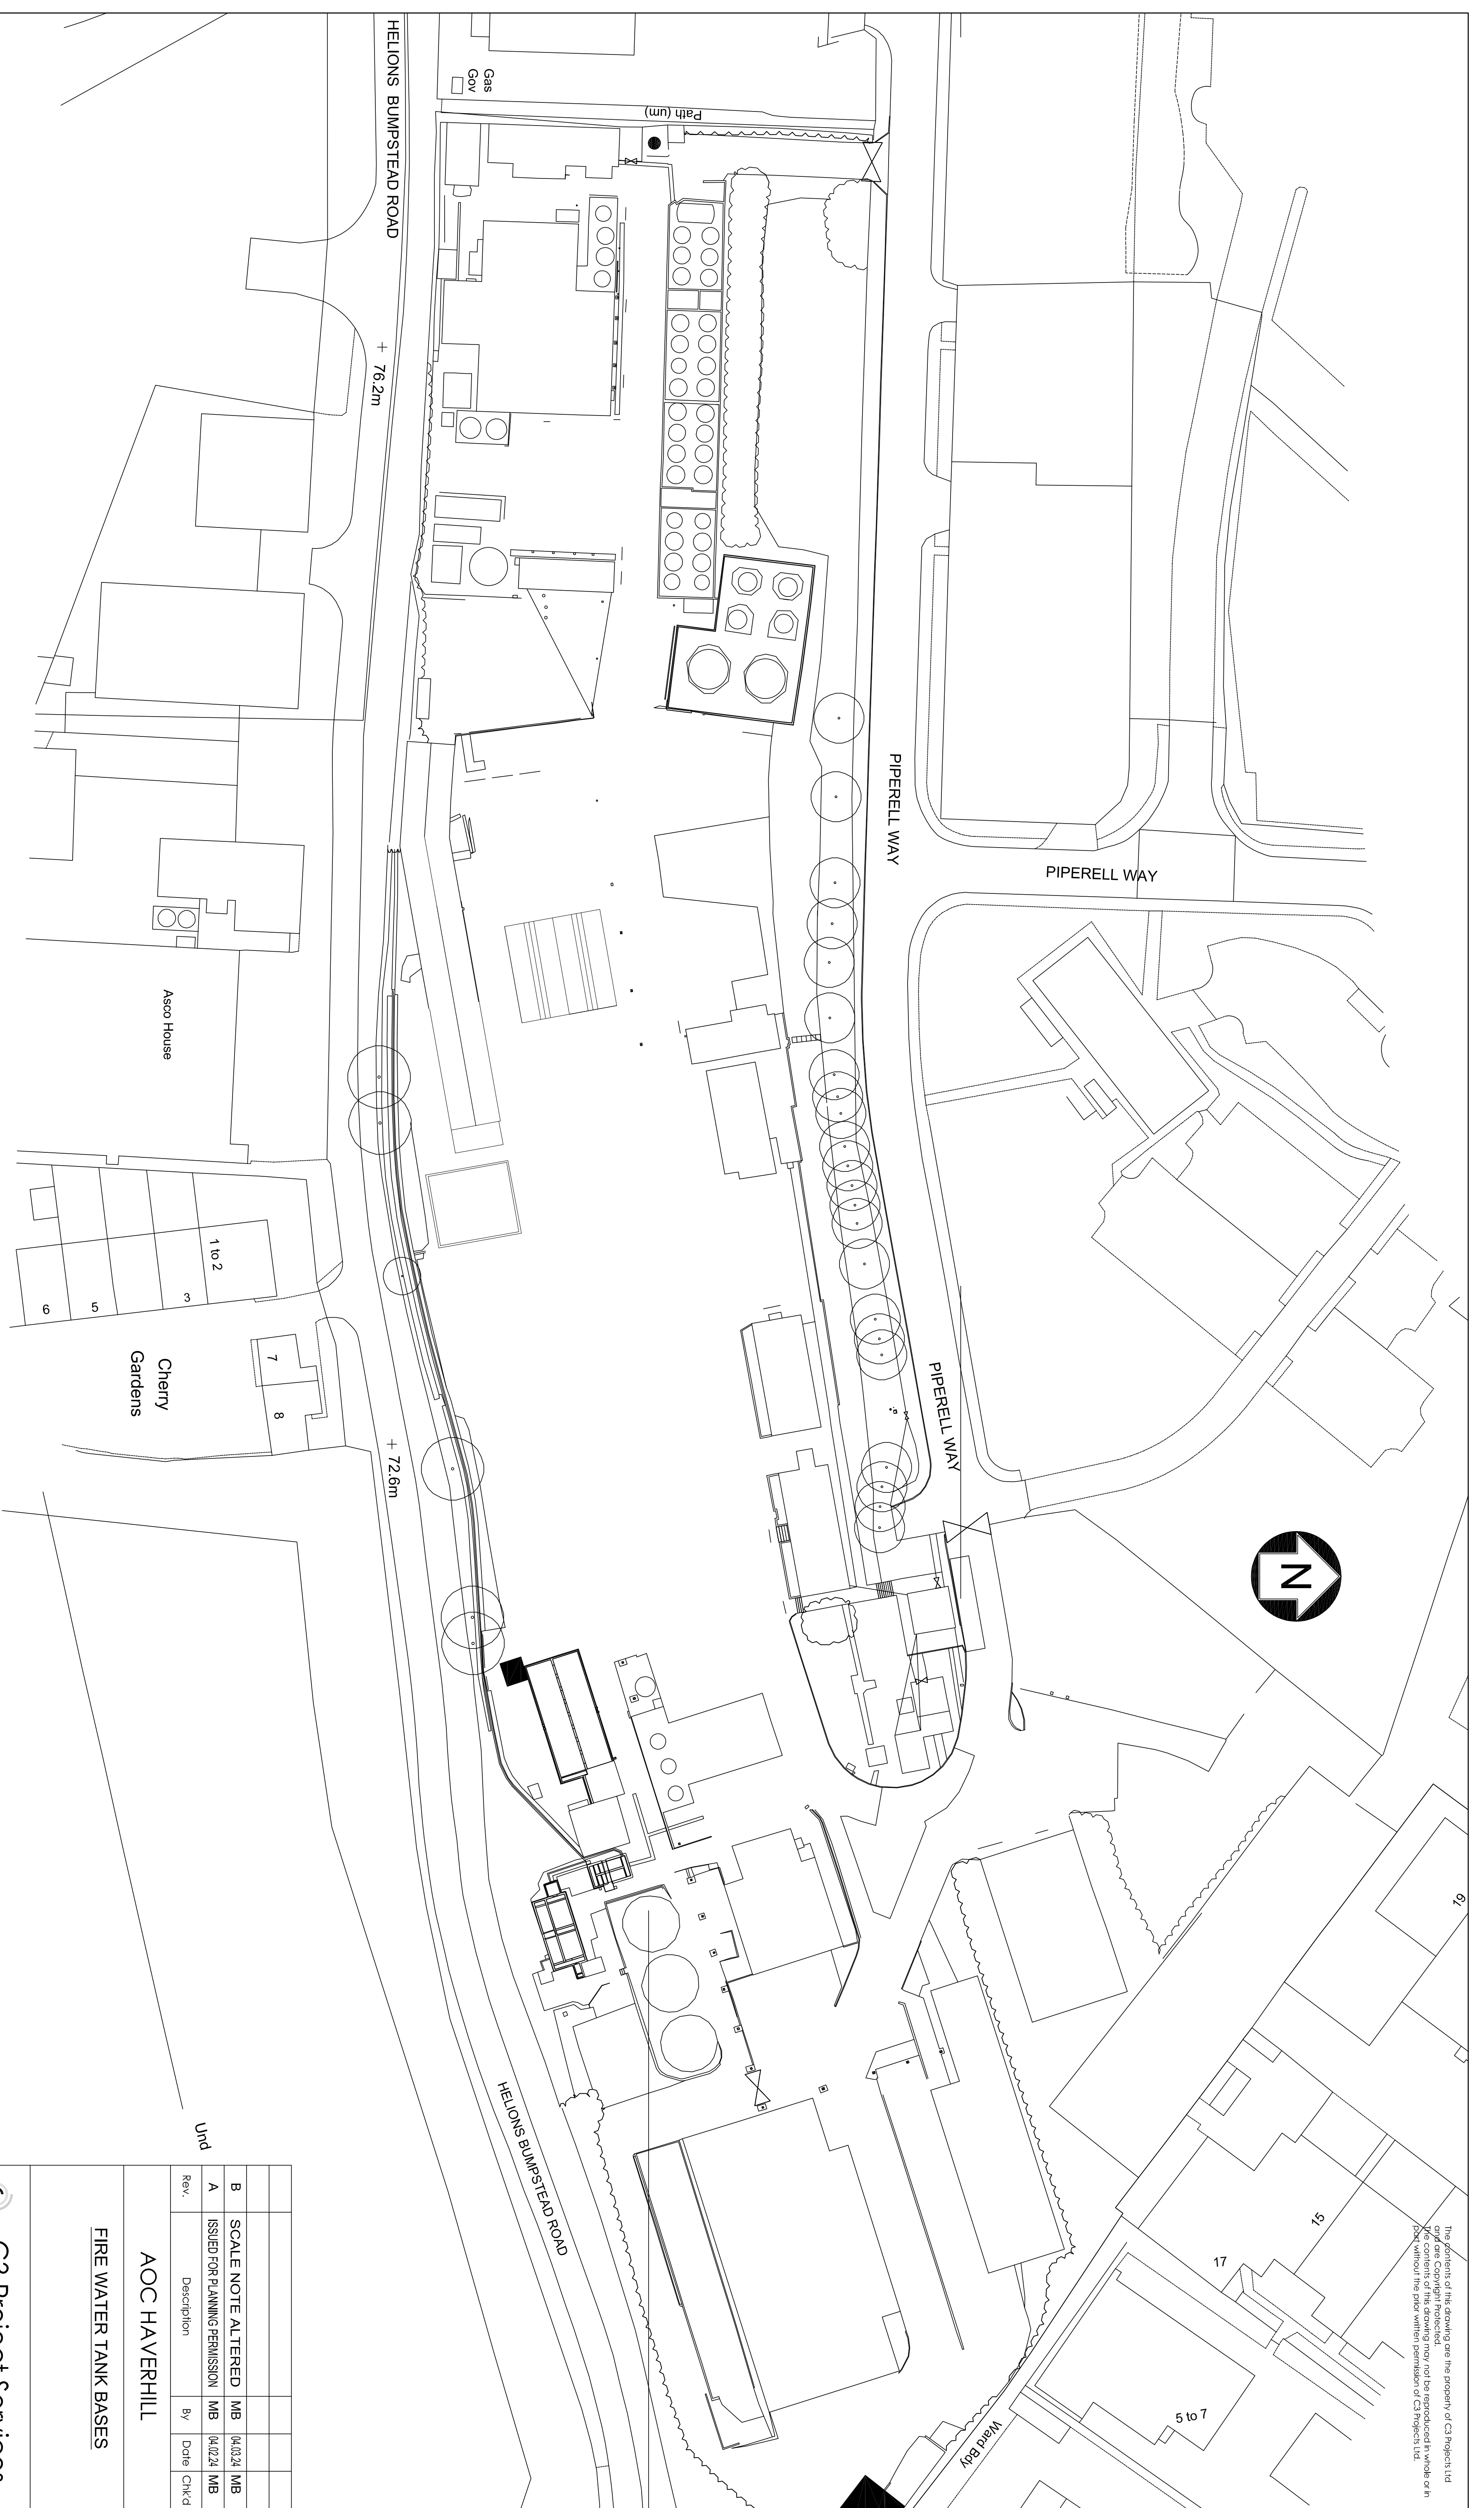

EXISTING SITE PLAN

FIRE WATER TANKS	
Contract No	TC-6900
EXISTING SITE PLAN	

Rev.	Description	By	Date	CHK'd
B	SCALE NOTE ALTERED	MB	04/02/24	MB
A	ISSUED FOR PLANNING PERMISSION	MB	04/02/24	MB

AOO HAVERHILL
FIRE WATER TANK BASES

C3 Project Services
C3 Technical Limited
59 Wilmslow Road,
Handforth,
Cheshire, SK9 3EN
Tel: 08456 789 869
email: info@c3projects.com
www.c3projects.com

Drawn By	MB	Date	JANUARY 2024
Checked By	MB	Scale	1:500 AT A1
Contract No	TC-6900	Drawing No	502
		Rev	B