


PROPOSED NORTH ELEVATION  
(LOOKING FROM PIPERELL WAY)

 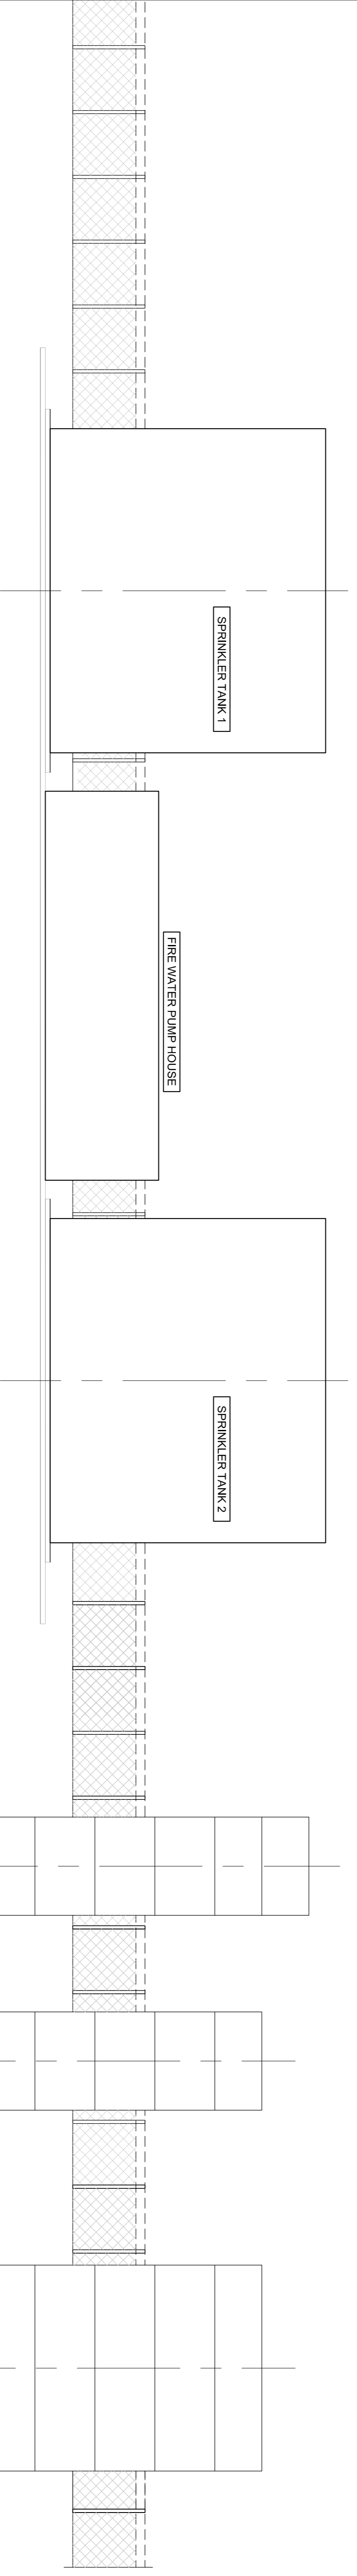


PROPOSED SOUTH ELEVATION  
(LOOKING TOWARDS PIPERELL WAY)

Rev.	Description	By	Date	CHK'd
C	DRAWING REVISED	MB	11.02.24	MB
B	DRAWING REVISED	MB	04.02.24	MB
A	ISSUED FOR PLANNING PERMISSION	MB	04.02.24	MB

**AOC HAVERHILL**

**FIRE WATER TANK BASES  
AT  
AOC, HAVERHILL**




**C3 Project Services**  
C3 Technical Limited  
59 Wilmslow Road,  
Handforth,  
Cheshire, SK9 3EN  
Tel: 08456 789 869  
email: info@c3projects.com  
www.c3projects.com

Drawn By	Date
MB	JANUARY 2024

Checked By	Scale
MB	1:100 AT A1

Contract No	Drawing No	Rev
TC-6900	603	C

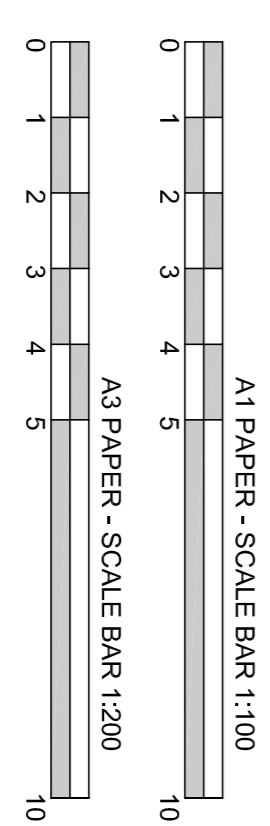

**FIRE WATER TANKS**

**PROPOSED ELEVATIONS - SHEET 1**