


PHASE: 2B							
MH No.	MANHOLE DIAMETER (mm)	MANHOLE TYPE	COVER LEVEL (m)	INVERT LEVEL (m)	DEPTH TO SOFFIT (m)	EASTING (m)	NORTHING (m)
HW2	---	HEADWALL	90.70	89.25	0.85	567228.074	246774.853
S16	1200	Type E	100.934	99.31	1.399	567358.924	246876.182
S17	1200	Type E	100.284	98.761	1.223	567353.915	246865.962
S18	1200	Type E	99.652	98.106	1.247	567350.659	246850.586
S19	1200	Type B	99.463	97.240	1.923	567343.699	246831.015
S20	1200	Type B	99.331	96.716	2.315	567339.640	246819.798
S21	1500	Type B	97.356	94.16	2.821	567281.168	246841.347
S22	1200	Type B	104.371	101.948	2.198	567400.022	246770.612
S23	1200	Type B	102.433	99.787	2.346	567370.701	246781.538
S24	1200	Type E	100.036	98.516	1.219	567334.963	246794.766
S25	1200	Type E	99.838	98.289	1.249	567325.871	246795.347
S26	1200	Type E	99.324	97.683	1.340	567317.248	246772.726
S27	1500	Type B	98.901	97.188	1.339	567311.546	246756.885
S28	1500	Type B	95.672	93.053	2.244	567265.568	246773.392
S29	1500	Type B	95.169	92.091	2.703	567255.971	246774.131
F26	1200	Type B	100.876	98.990	1.736	567360.207	246873.063
F27	1200	Type B	100.273	98.544	1.579	567355.858	246863.765
F28	1200	Type B	99.687	97.874	1.663	567352.911	246848.628
F29	1200	Type B	99.508	96.943	2.414	567345.579	246828.533
F30	1200	Type B	99.410	96.590	2.670	567342.823	246821.118
F31	1200	Type A	97.356	93.698	3.508	567280.432	246843.718
F32	1200	Type B	104.467	101.702	2.615	567403.346	246772.06
F33	1200	Type B	102.529	99.539	2.840	567372.862	246783.142
F34	1200	Type B	99.812	98.020	1.642	567329.924	246798.389
F35	1200	Type B	99.337	97.341	1.846	567319.045	246769.848
F36	1200	Type B	99.077	96.953	1.974	567312.913	246753.476
F37	1200	Type B	95.458	93.31	1.998	567261.530	246772.070
F38	1200	Type E	93.278	91.85	1.278	567238.736	246797.448

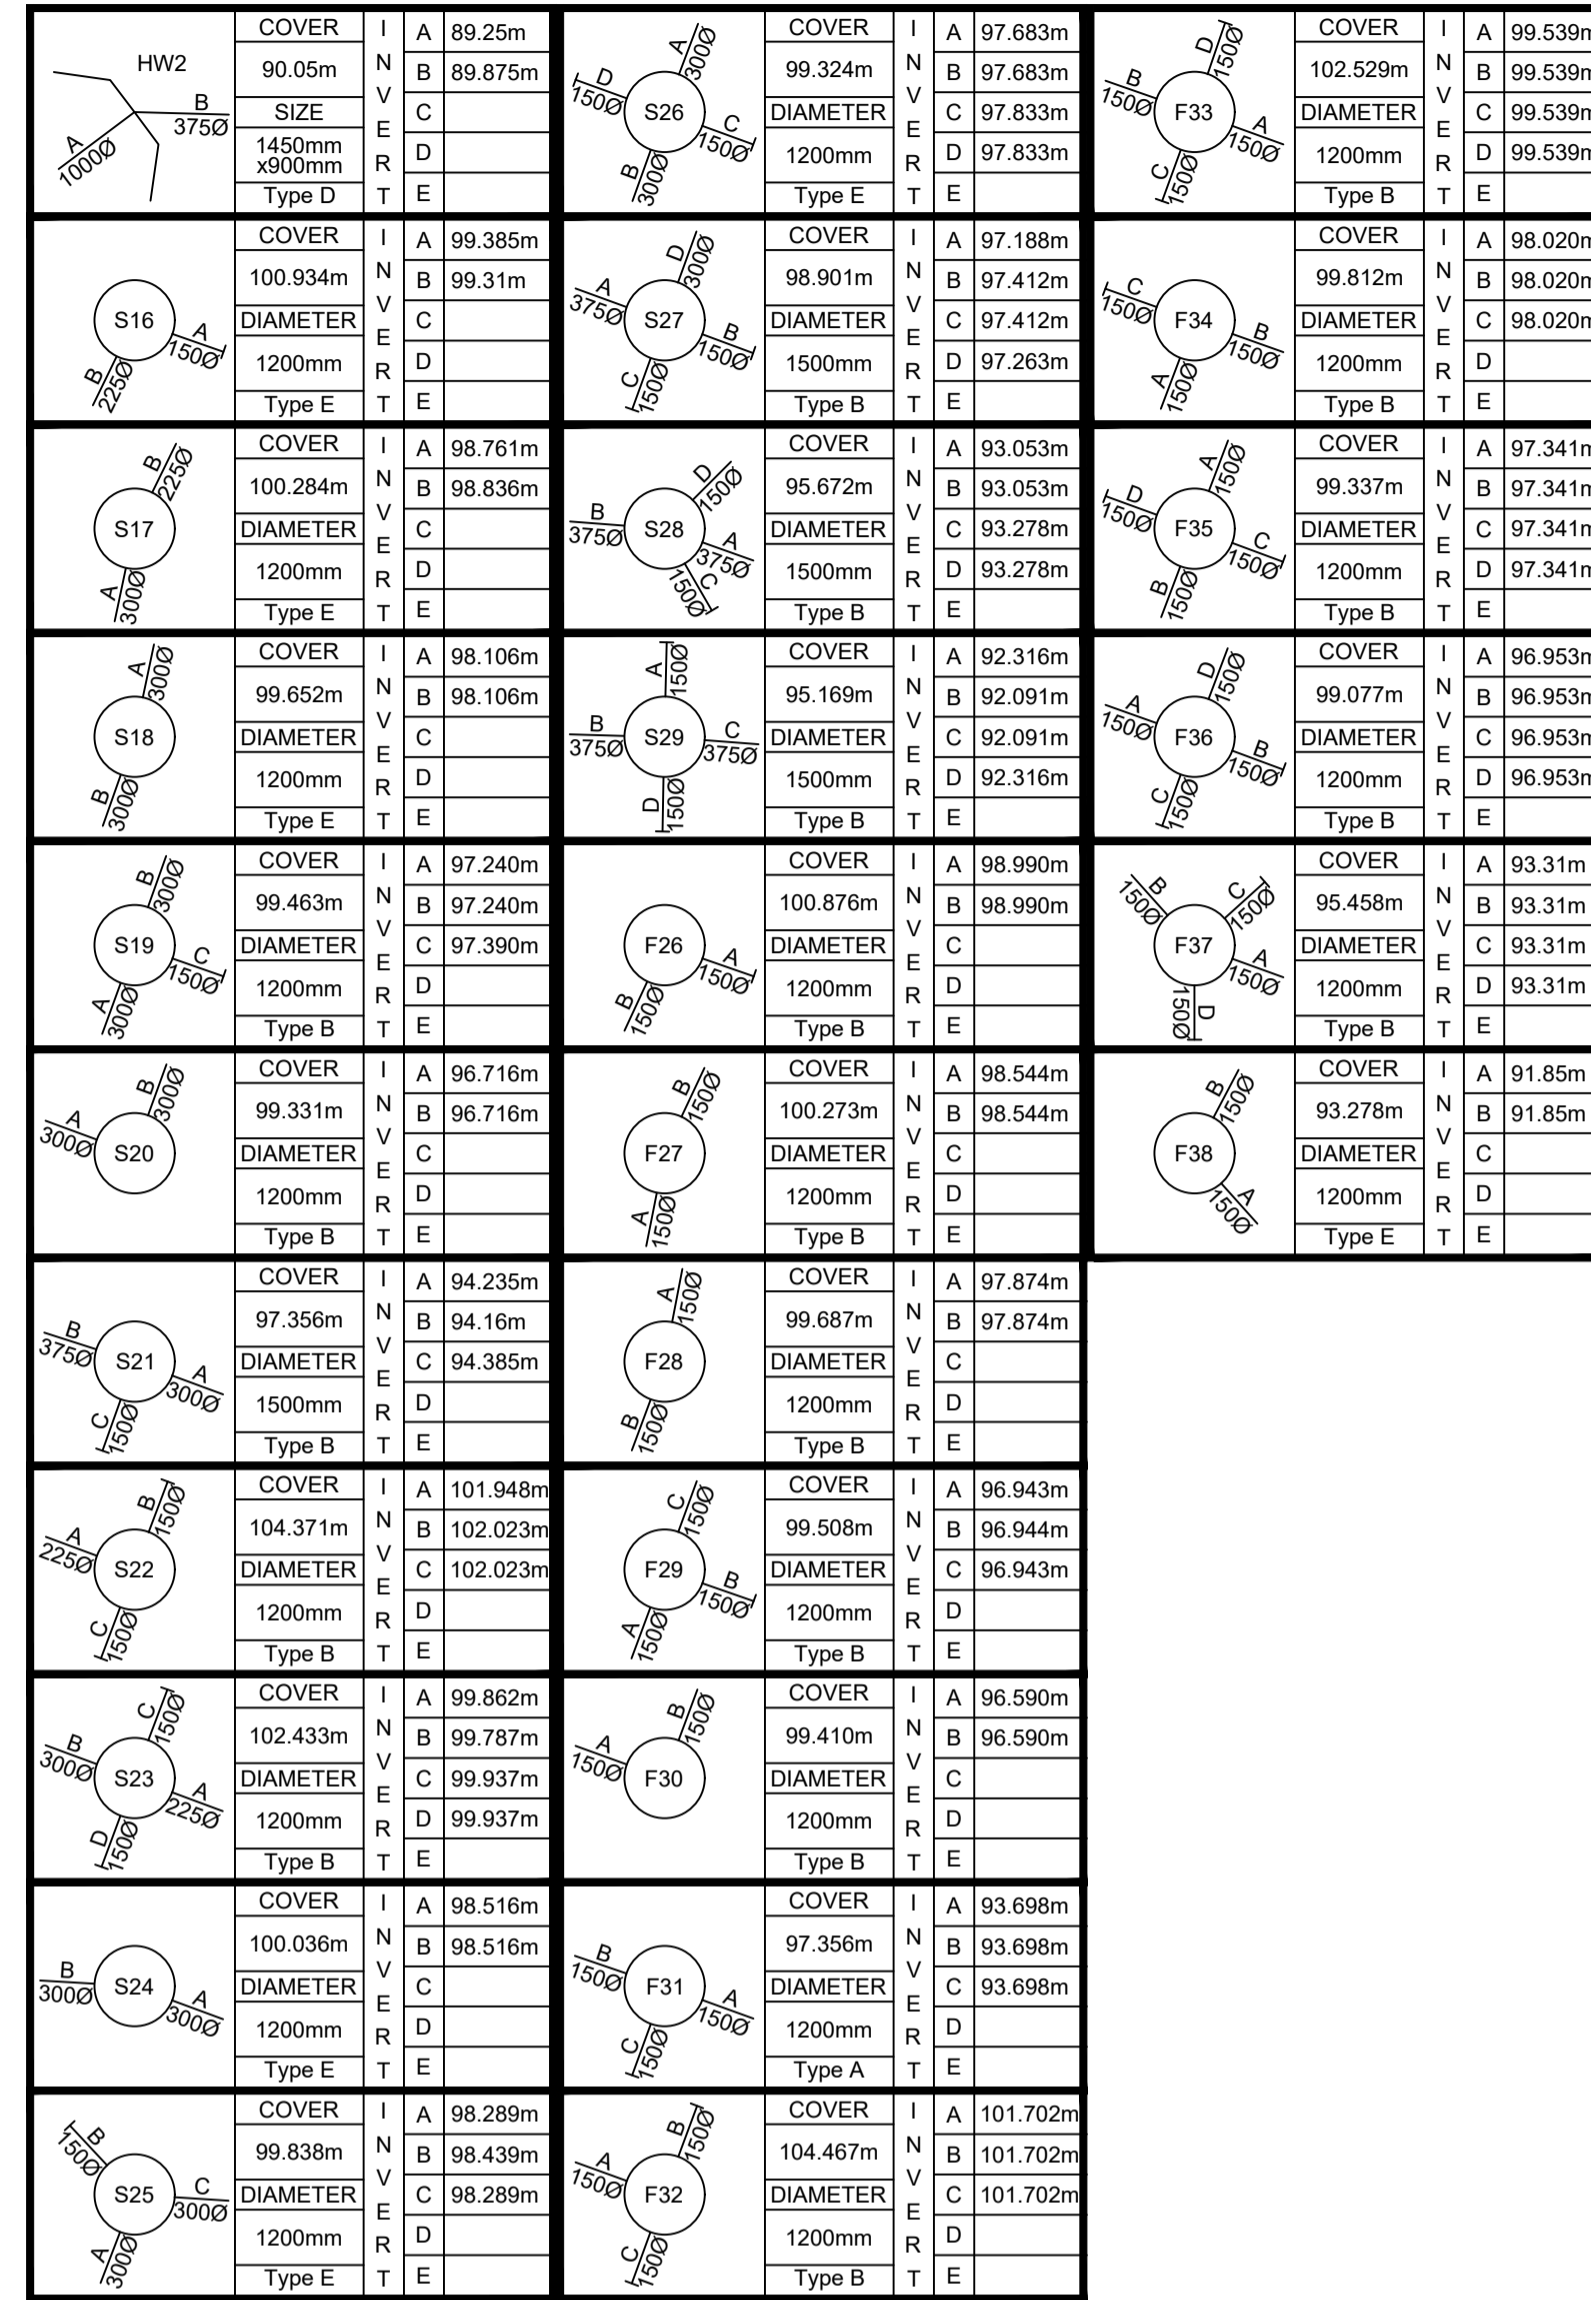

Rev	Description	Date	Drawn	Checked
A	Manhole schedule updated to suit drainage layout	14.06.21	AS	PW


Drawing Approval Status:-
 N/A Section 104 N/A Section 38 N/A Section 278

FOR APPROVAL



Project:
 Haverhill, Boyton Place - Phase 2b

Drawing Description:
 Manhole Schedules

Client:

 Persimmon Homes (Suffolk)
 Persimmon House
 Orion Court, Orion Avenue
 Great Blakenham
 Suffolk IP6 0LW

Drawing Number:
 E4062/545/A

Client Reference:

Scale:
 NTS @ A1
 NTS @ A3

Designed By: TJW Drawn By: JMW Checked By:
 Date: 11.01.21 Date: 19.01.21 Date:

Certified by Afnor UK