



Rev:	Description:	By:	Date:
------	--------------	-----	-------

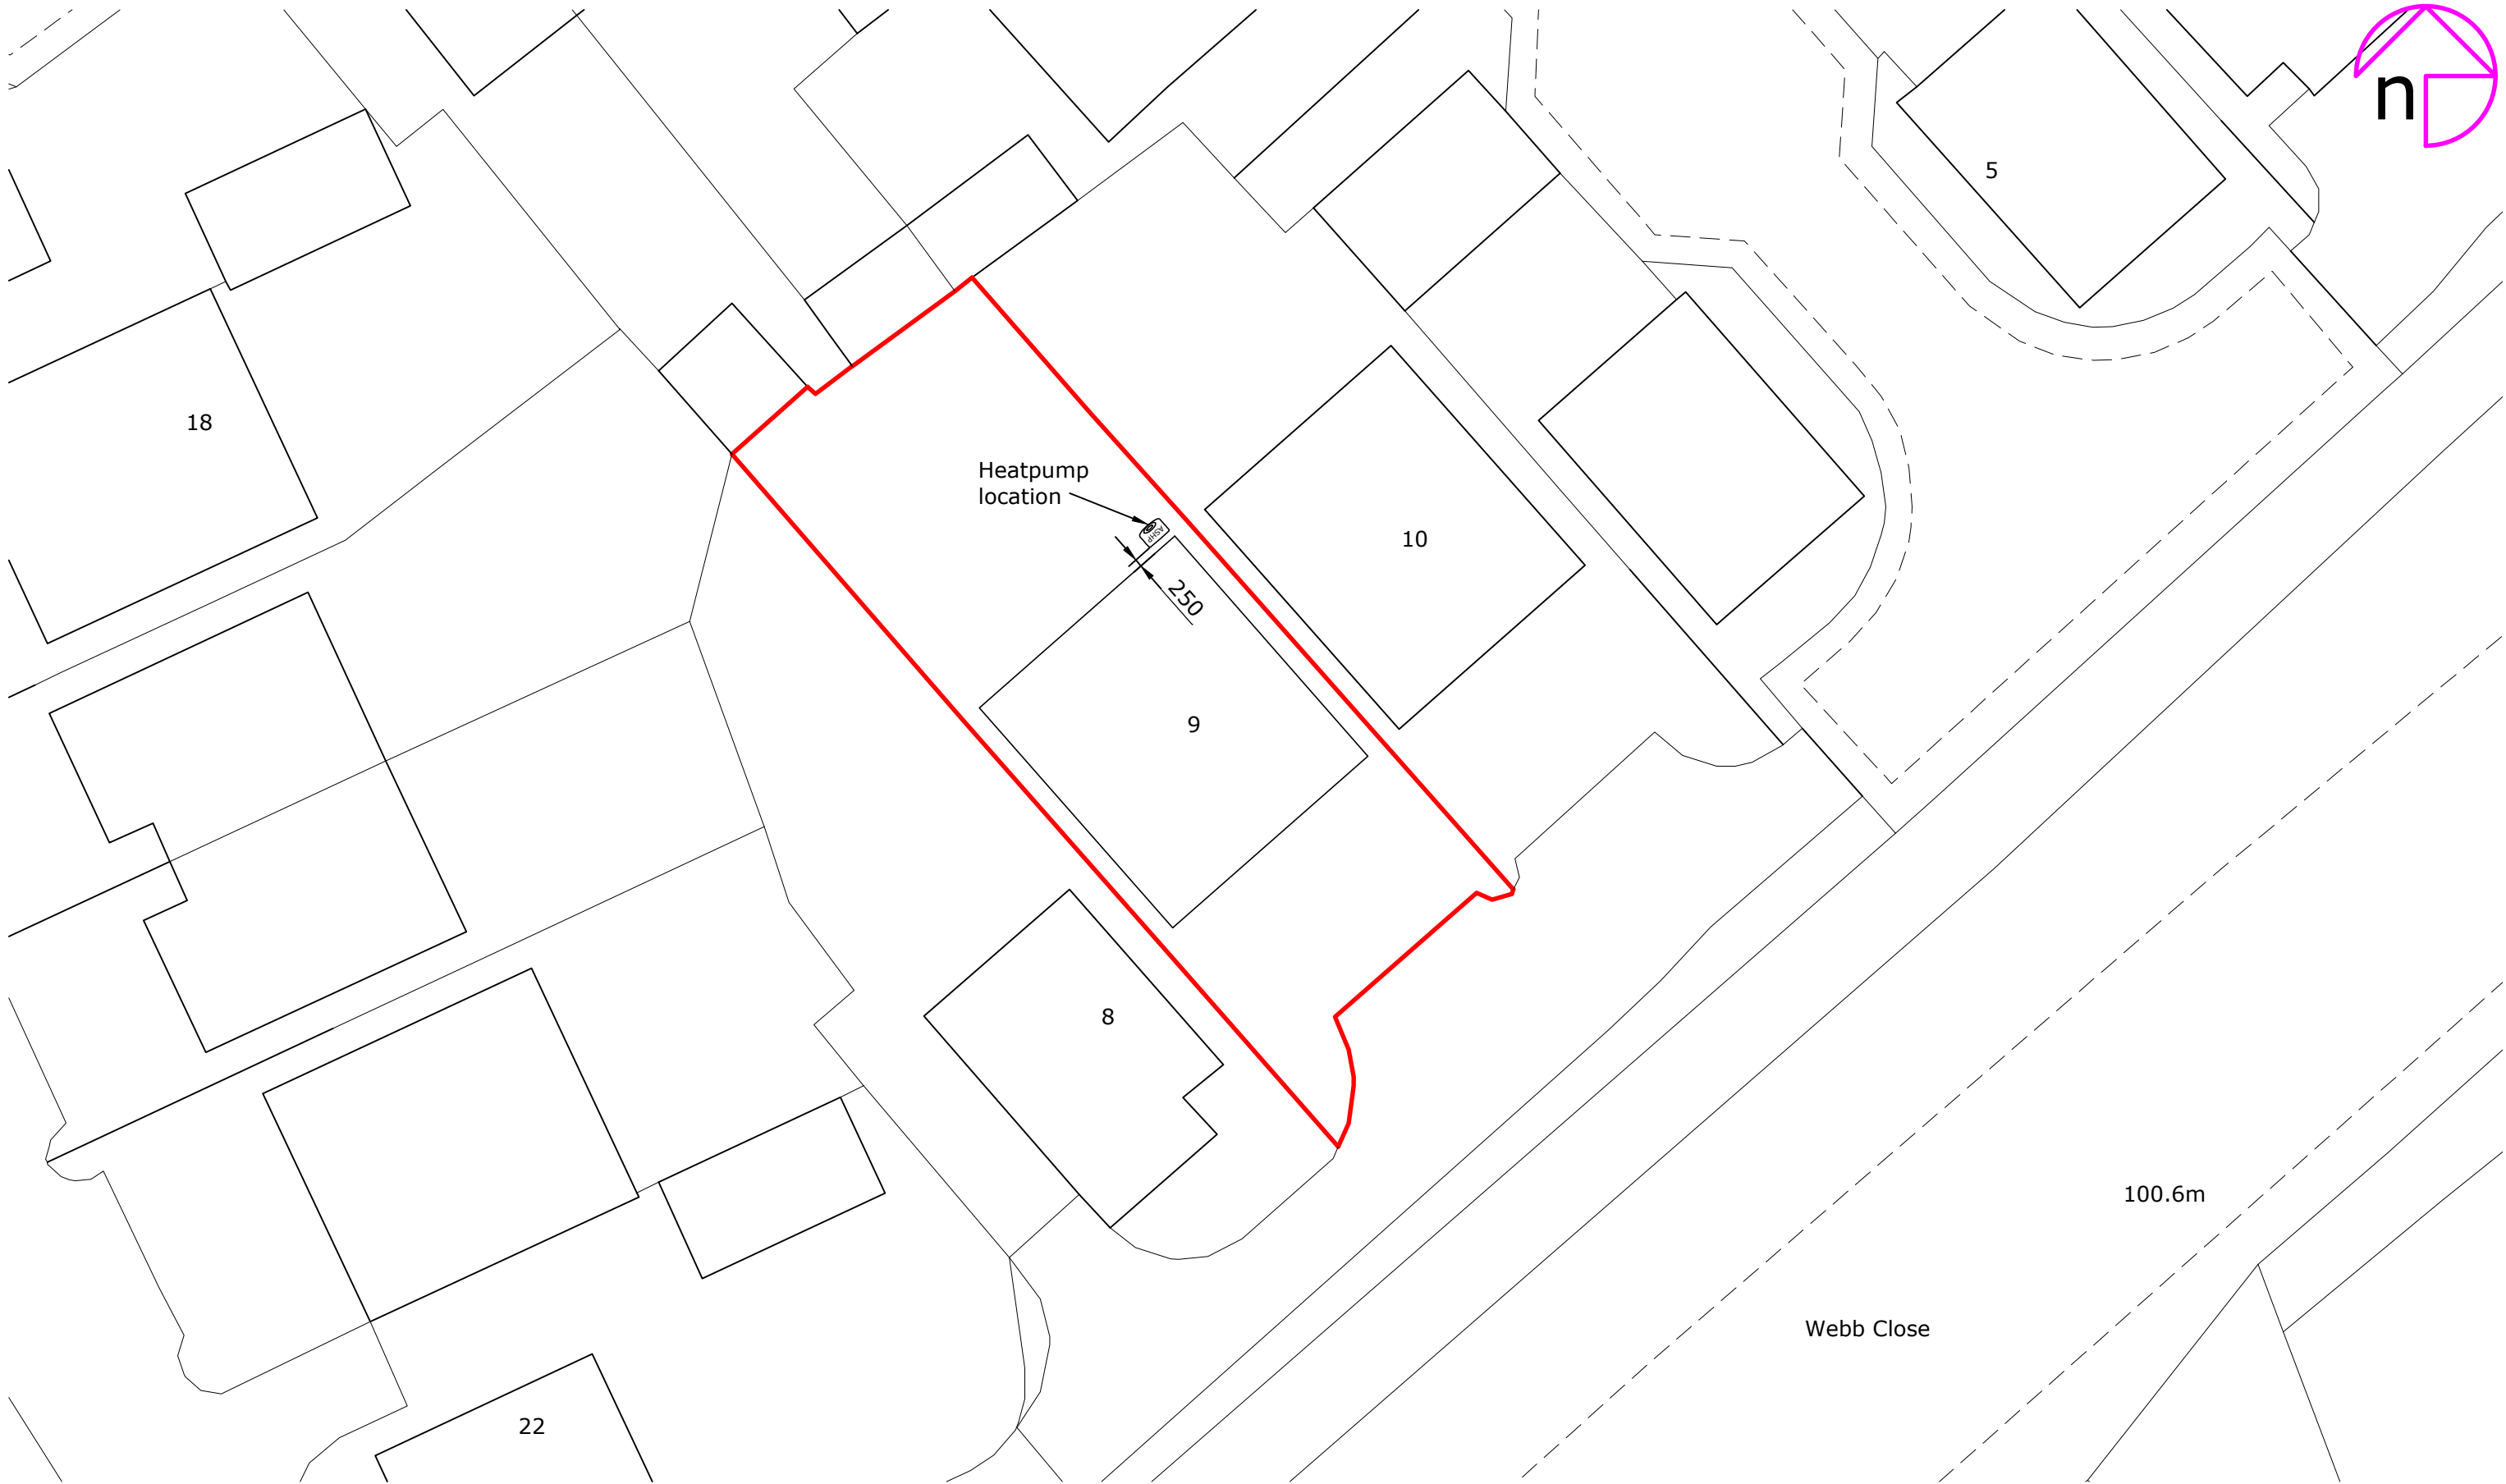

octopusenergy
SERVICES

Accredited by:

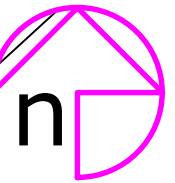

Client/Project: Andrew Brown, 9 Webb Close, Haverhill CB9 7HW	Project status: PLANNING Drawing title:Site plan as proposed showing location of air source heat pump
--	---

Scale: 1:200	Paper Size: A3	Drawn: A.K.	Checked: AB
Project ID: J-E851E3CE	Drawing No: 02	Revision:	Date: May 2026