




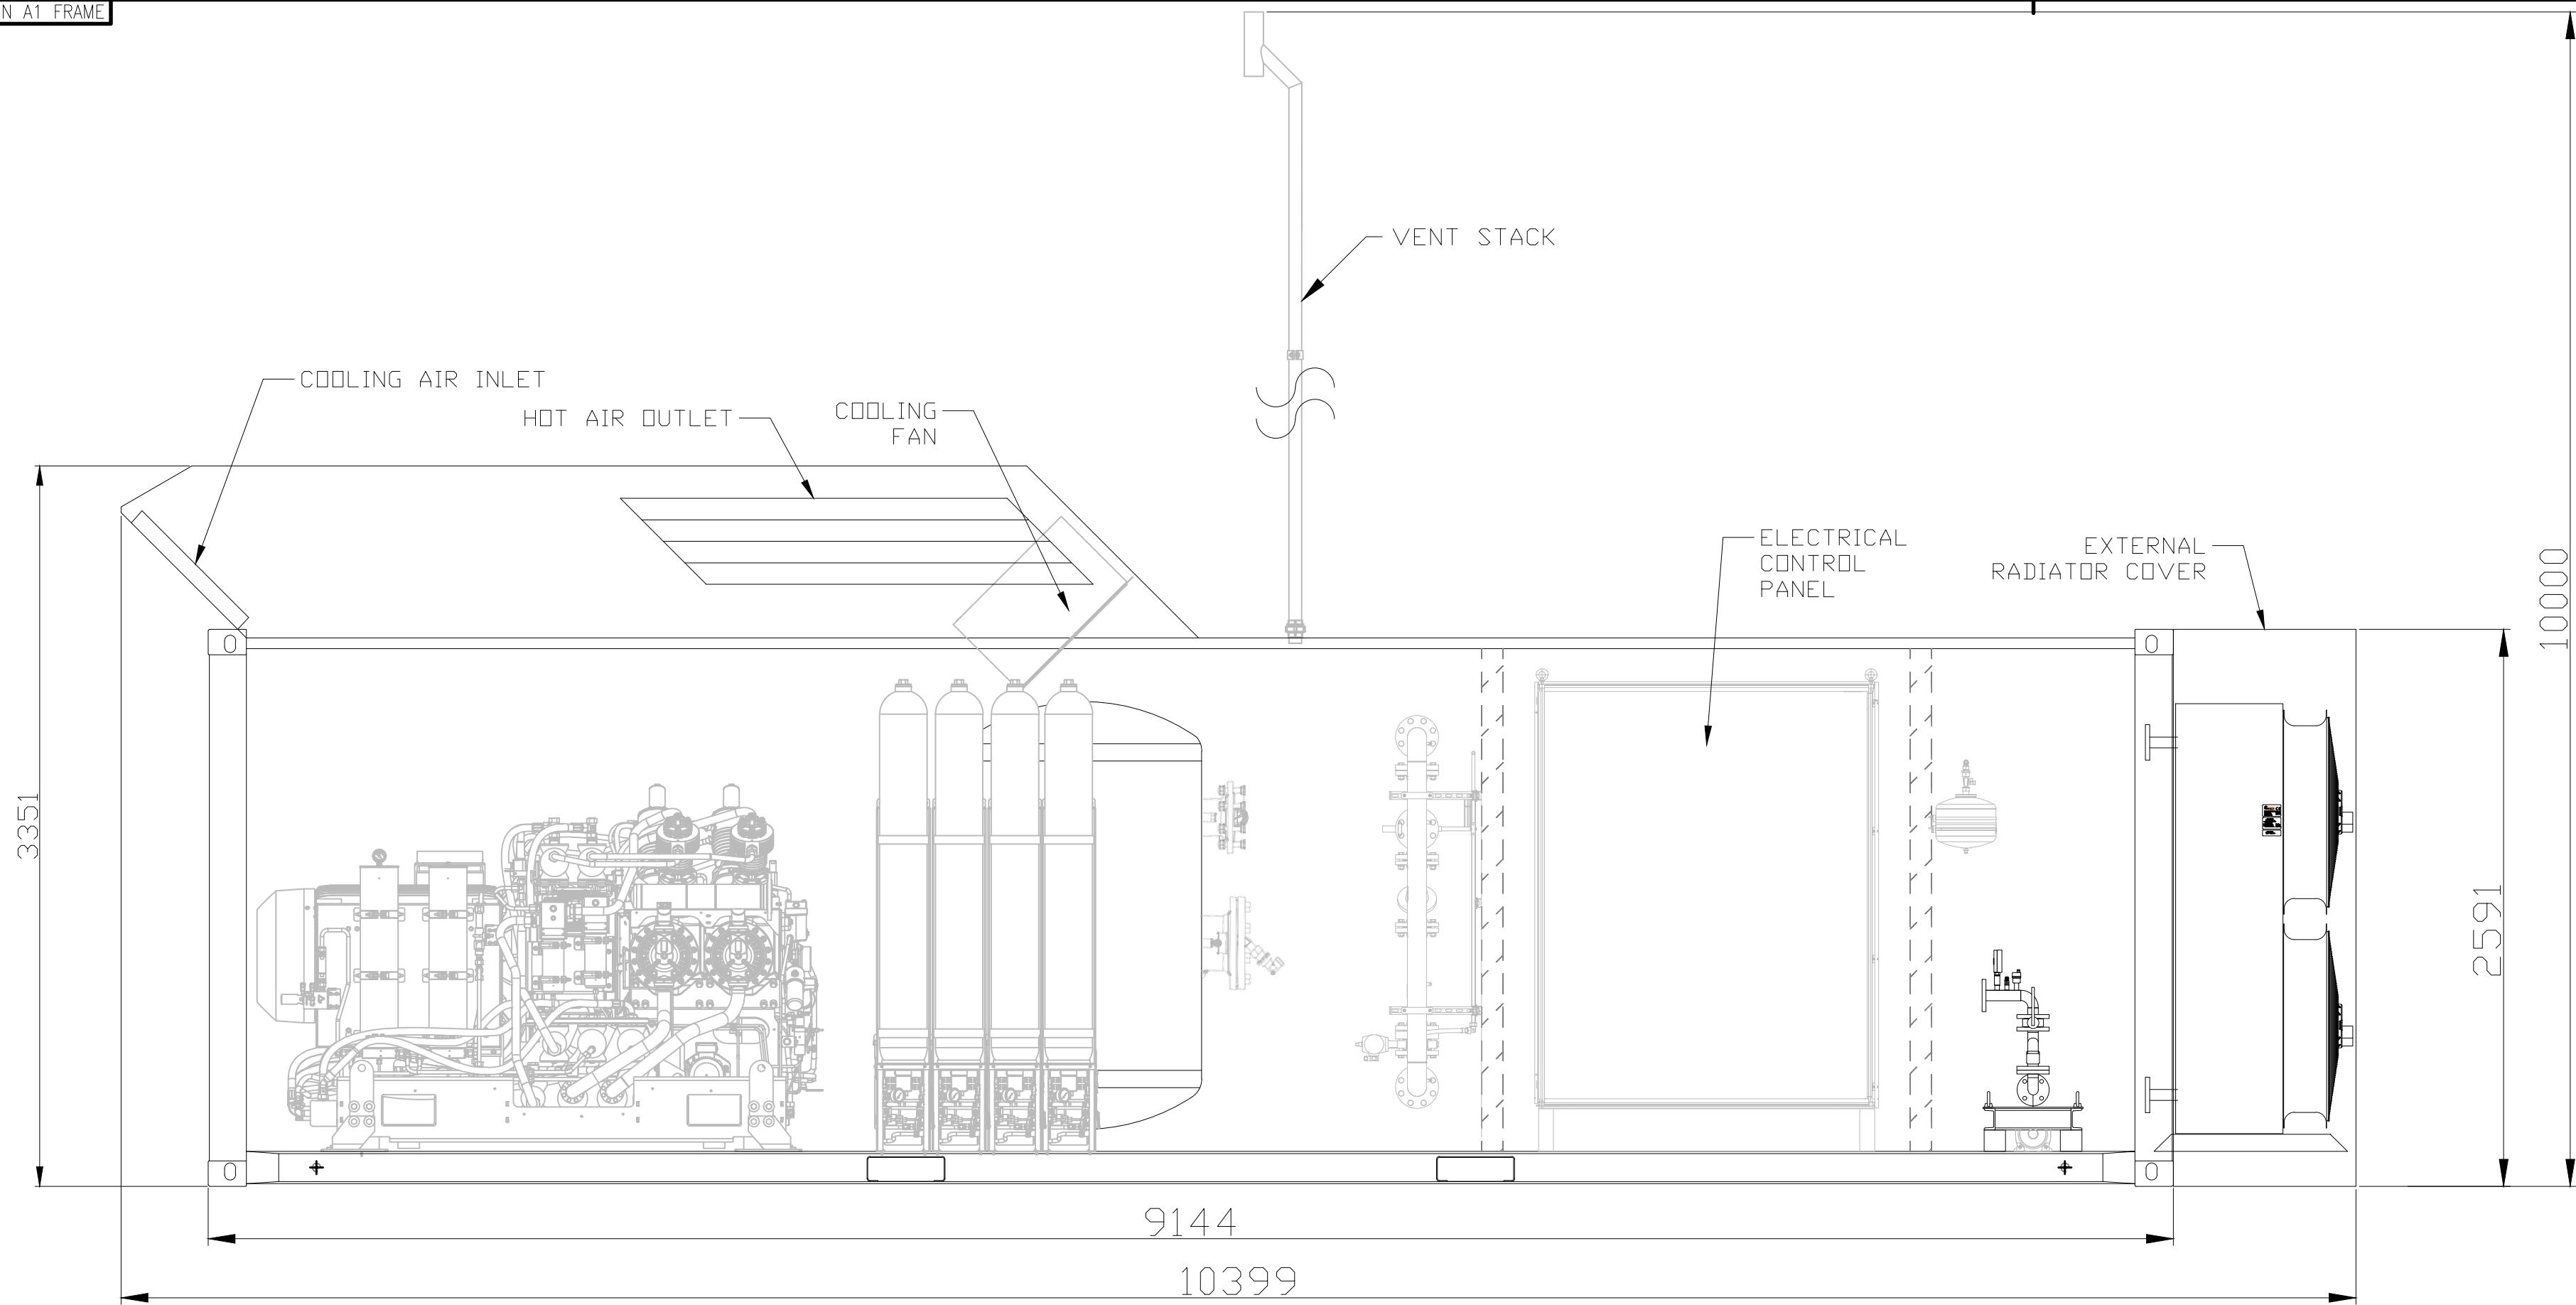


FRONT VIEW

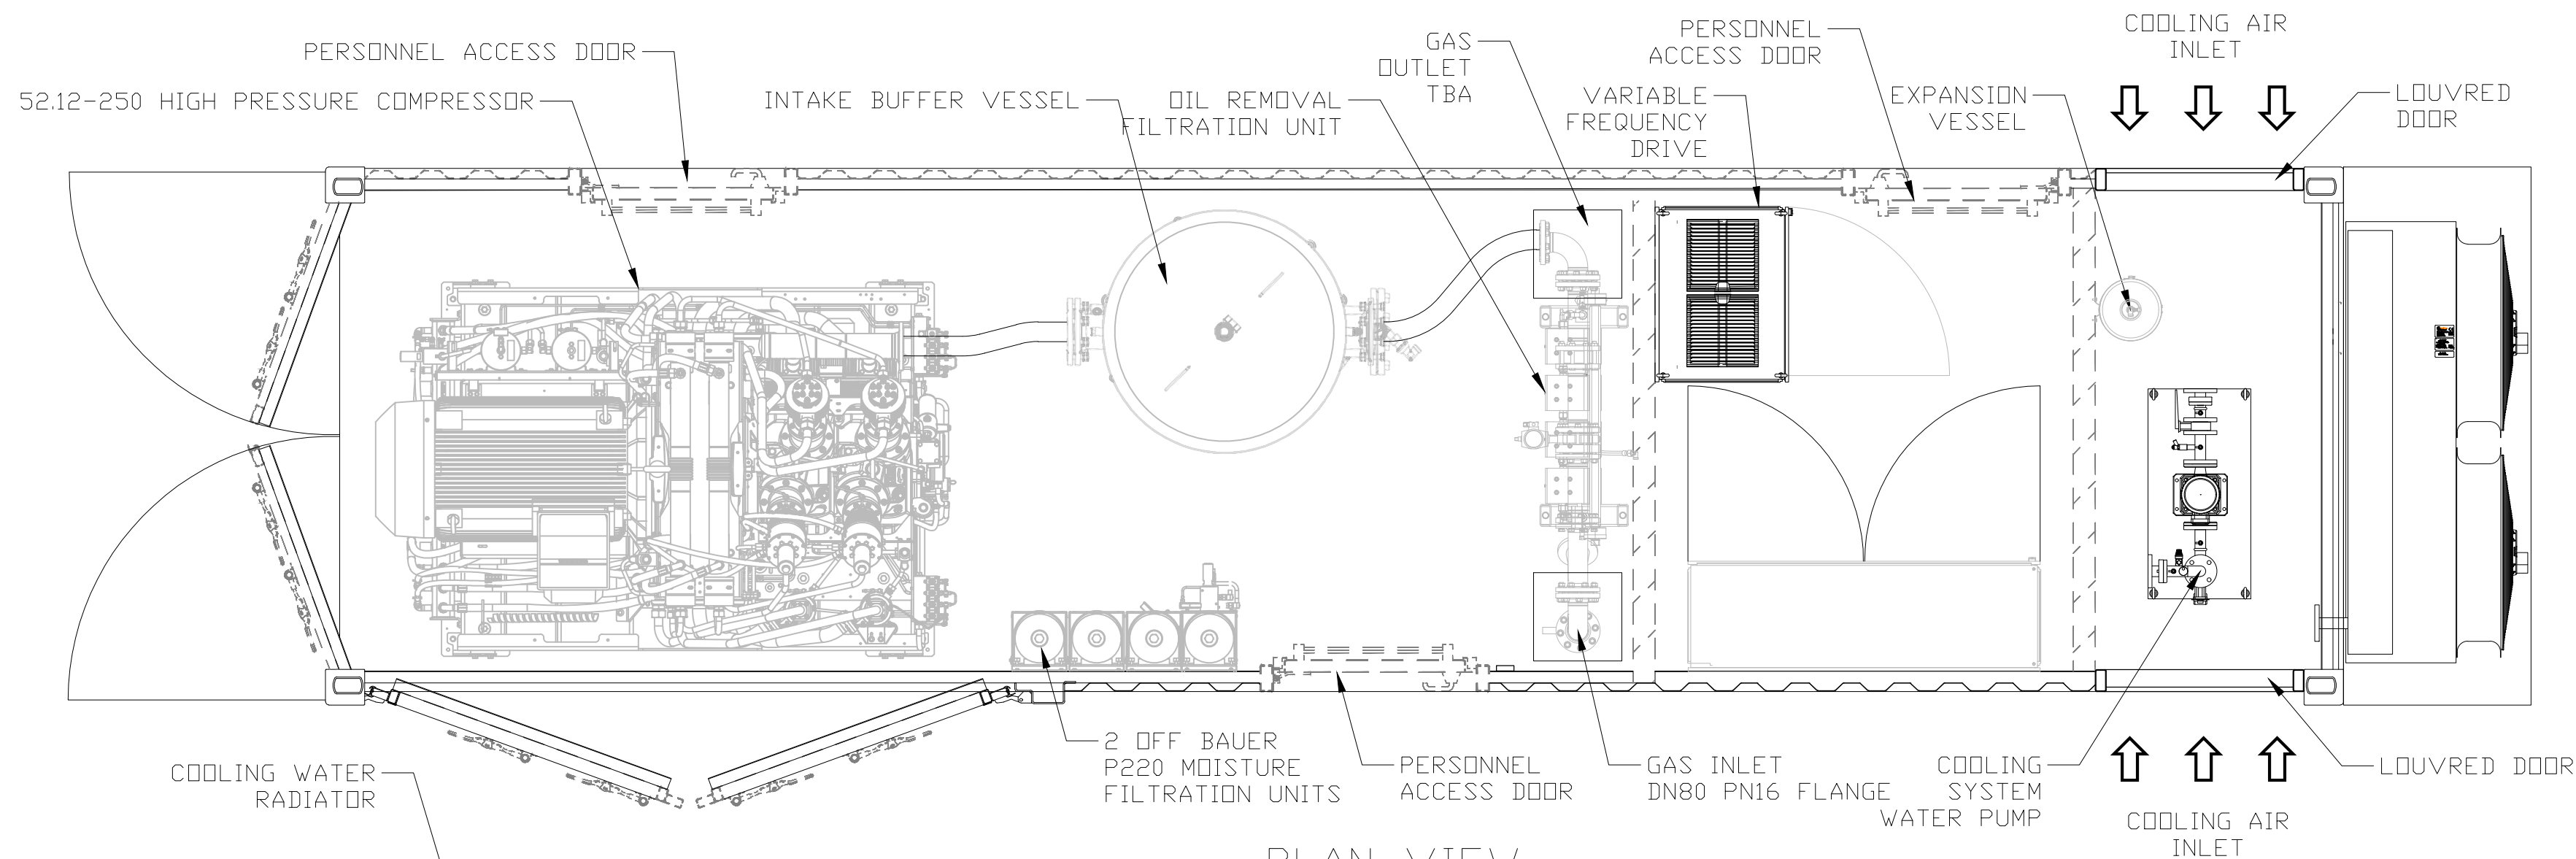

PLAN VIEW
ROOF DUCTING OMITTED FOR CLARITY

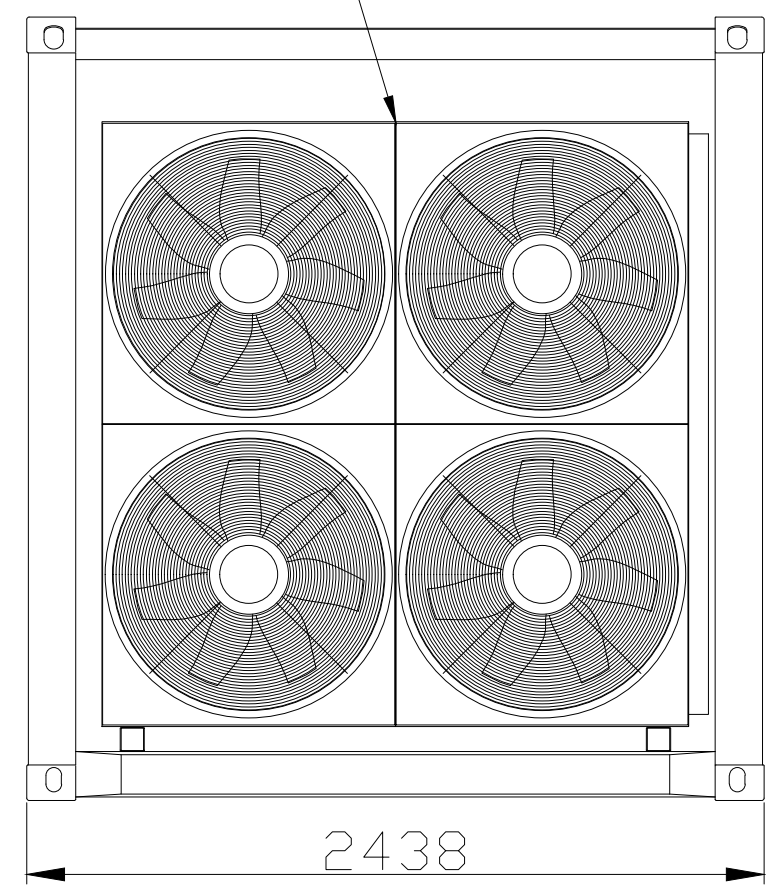

SIDE VIEW

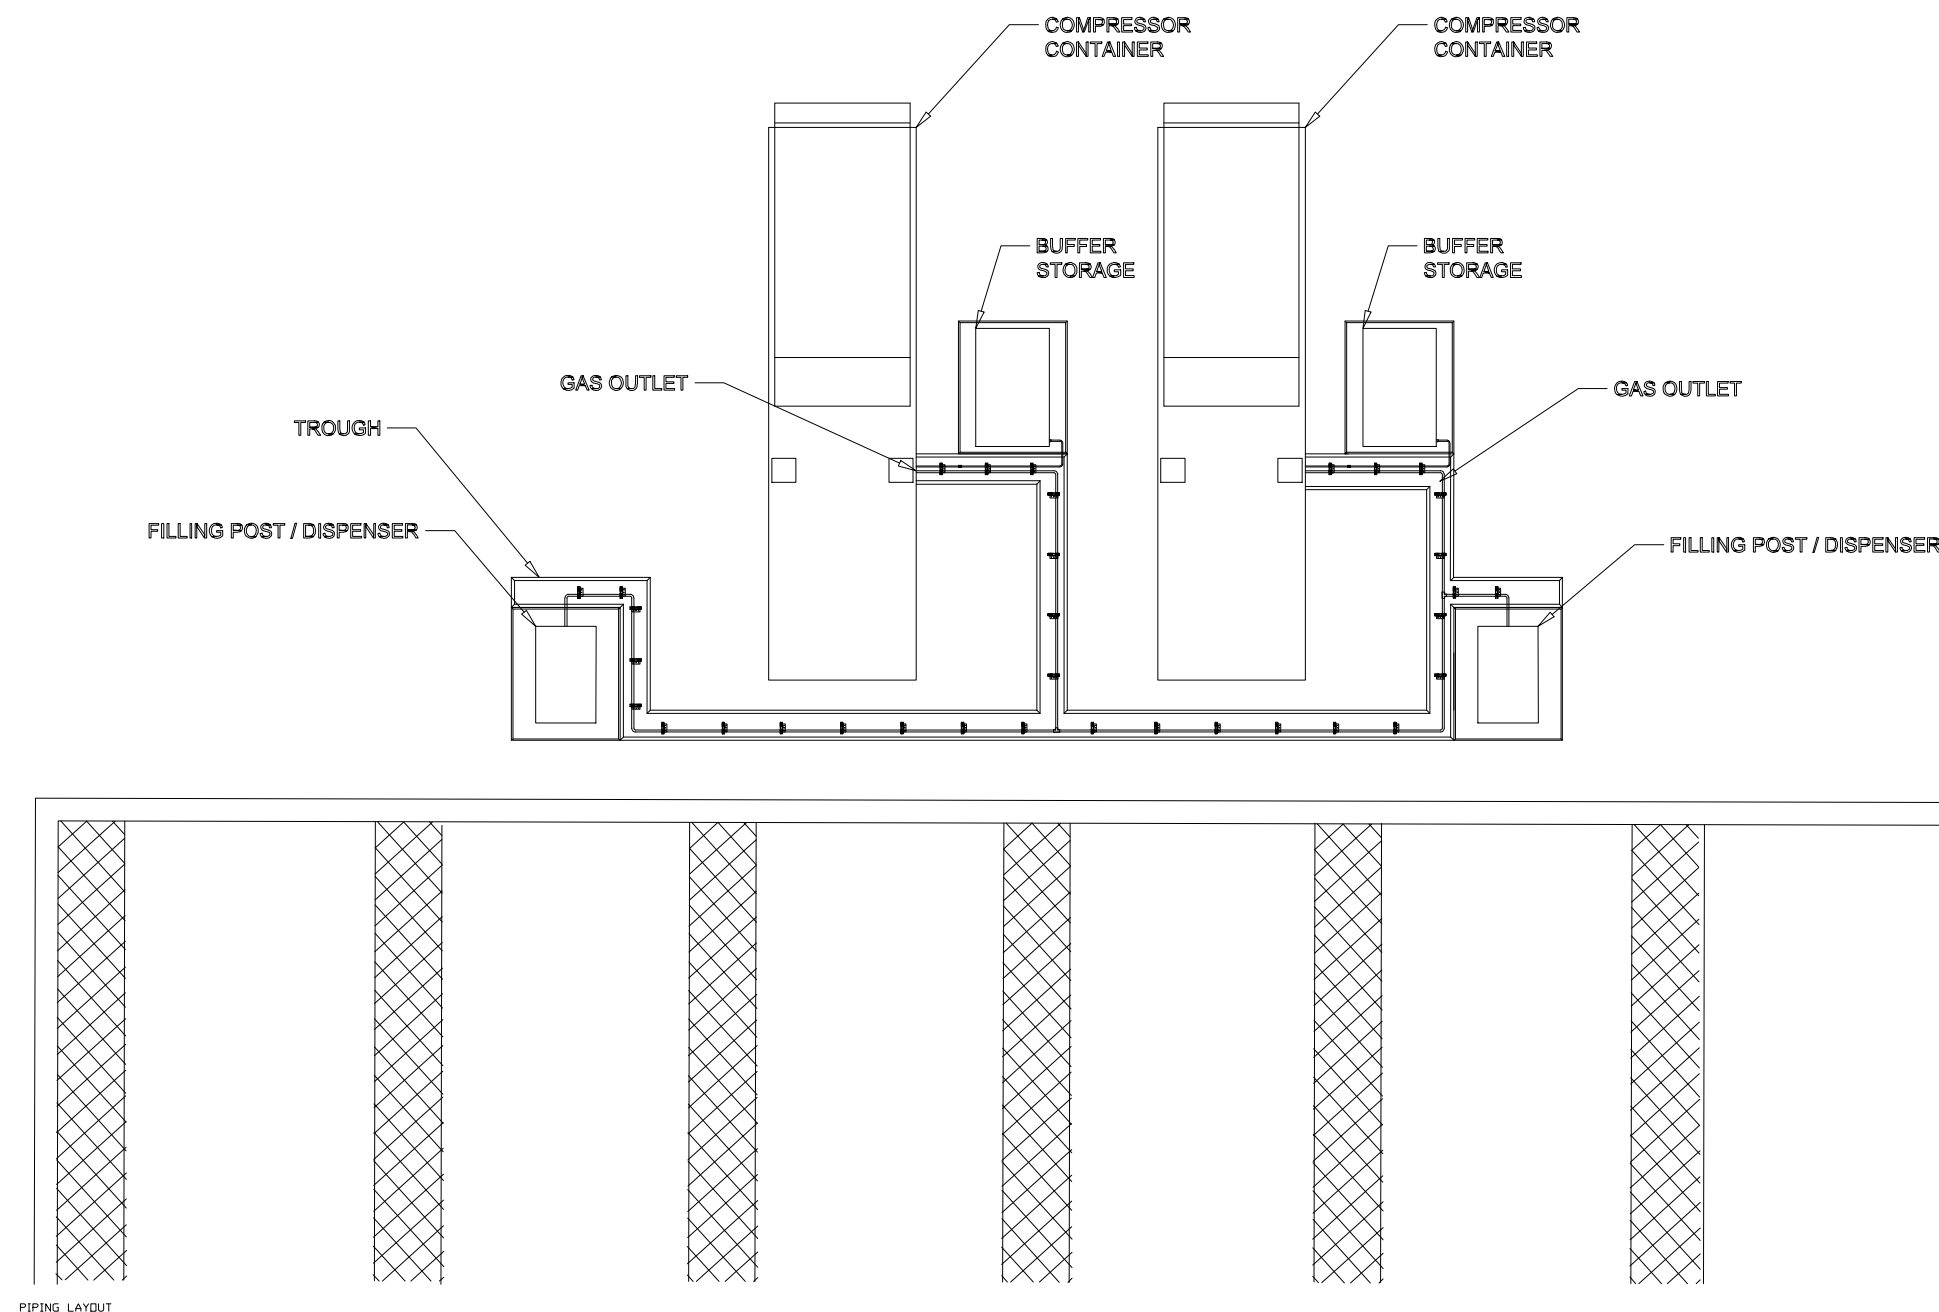

P1	28/04/23	Issued For Planning	mg	JHC
Rev	Date	Description	DR	CH
© copyright				
				
				
				
		CONSULTING ENGINEERS PROJECT MANAGEMENT		
		2 Hallam Road Priory Park East HULL HU4 7DY United Kingdom		
		Telephone(+44) 01482 627963 Fax (+44) 01482 641736 Email info@ggpconsult.co.uk		
Client				
Job Title		AD Plant Developments.		
Drawing Title		Compressor – Plans, Elevations & Piping Layout.		
Status		Planning		
Scale	1:125 & 25	Date	April '23	
Drawn By	mg	Checked	JHC	Approved JHC
Dwg. No.	29428/E/108	Rev	P1	